


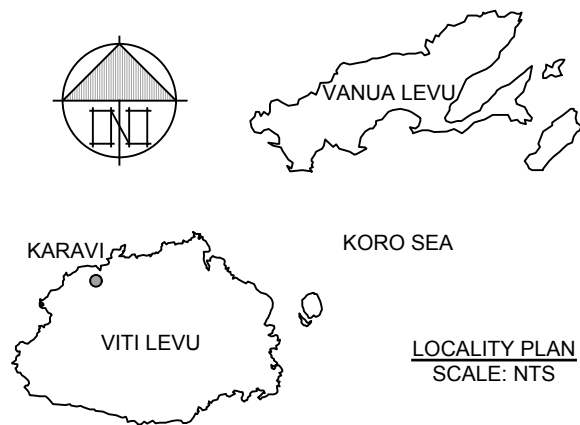

 



 

 

 



 









 



7835 FIRE PROTECTION SERVICES SCHEDULE OF DRAWINGS		
DWG#:	SHEET TITLE	SCALE
F01	SCHEDULE OF DRAWINGS, LOCALITY PLAN, LEGENDS & ABBREVIATIONS	NTS
F02	SPECIFICATION & SCOPE OF WORKS	NTS
F03	PROPOSED SITE PLAN FIRE PROTECTION LAYOUTS	1 : 250 @ A3
F04	PROPOSED FLOOR PLANS FIRE PROTECTION LAYOUTS	1 : 100 @ A3
F05	PROPOSED FIRE PROTECTION DETAILS	NTS

PROPOSED FIRE ABBREVIATIONS	
ABBREVIATIONS	DESCRIPTIONS
CO <sub>2</sub>	CARBON DIOXIDE
DP	DRY POWDER
FB	FIRE BLANKET
FHR	FIRE HOSE REEL
FIU	FIRE INDICATING UNIT
NTS	NOT TO SCALE
SS	STAINLESS STEEL
WP	WEATHER PROOF
	CIRCLE WITHIN DIAMOND ENCLOSED LETTER INDICATES SPECIFIC NOTE REFERENCE ON SAME SHEET
	TRIANGLE WITH A NUMBER INSIDE INDICATES DRAWING REVISION
	D# : INDICATES THE DETAIL NUMBER F# : INDICATES THE FIRE PROTECTION SHEET NUMBER



FIRE PROTECTION SERVICES LEGEND OF SYMBOLS		
FIRE ALARM SYSTEM		
IMAGE	SYMBOLS	DESCRIPTIONS
		FIRE INDICATING UNIT - RECESSED
		AUDIBLE ALERTING DEVICE - ALARM SOUNDER (FOR USE IN SMALLER ROOMS) WP - DENOTES AN IP65 RATED TYPE FOR OUTDOOR APPLICATIONS
		MANUAL CALL POINT RED - SURFACE MOUNTED - CONNECTED TO FIU WP - DENOTES AN IP65 RATED TYPE FOR OUTDOOR APPLICATION
		VISUAL ALERTING DEVICE W - DENOTES WALL MOUNTED WP - DENOTES AN IP65 RATED TYPE FOR OUTDOOR APPLICATION
		THERMAL DETECTOR
		IN CEILING THERMAL DETECTOR WITH REMOTE INDICATOR
		SMOKE DETECTOR

FIRE EXTINGUISHERS		
IMAGE	SYMBOLS	DESCRIPTIONS
	DP-# 	DRY POWDER TYPE - WITH SIGNAGE NUMBER # INDICATES THE NET WEIGHT OF THE EXTINGUISHANT IN KILOGRAMS
	CO <sub>2</sub> -# 	CARBON DIOXIDE TYPE - WITH SIGNAGE NUMBER # INDICATES THE NET WEIGHT OF THE EXTINGUISHANT IN KILOGRAMS
	DP-# 	DRY POWDER TYPE IN CABINET - WITH SIGNAGE NUMBER # INDICATES THE NET WEIGHT OF THE EXTINGUISHANT IN KILOGRAMS
	CO <sub>2</sub> -# 	CARBON DIOXIDE TYPE IN CABINET - WITH SIGNAGE NUMBER # INDICATES THE NET WEIGHT OF THE EXTINGUISHANT IN KILOGRAMS
	FB-1.2 	FIRE BLANKET - WITH SIGNAGE NUMBER INDICATES THE AREA OF THE BLANKET WHEN COMPLETELY UNFOLDED (1.2m x 1.2m)

PROPOSED FIRE SUPPRESSION LEGEND	
SYMBOLS	DESCRIPTIONS
 FHR	STAINLESS STEEL FIRE HOSE REEL, 36m IN STAINLESS STEEL CABINET TYPE, SUPPLY & INSTALLATION BY FIRE PROTECTION SUB-CONTRACTOR



**LOCALITY PLAN**  
NTS

© COPYRIGHT OF THIS DRAWING SHALL REMAIN THE PROPERTY OF IRWIN ALSOP PACIFIC PTE LTD. PRECEDENCE SHALL BE GIVEN TO THE LARGEST SCALE DRAWING. THE CONTRACTOR SHALL VERIFY ALL DIMENSIONS ON SITE PRIOR TO PREPARATION OF SHOP DRAWINGS OR COMMENCEMENT OF ANY WORK. THE ENGINEER SHALL BE NOTIFIED IMMEDIATELY OF ANY DISCREPANCIES.	<b>LEAD CONSULTANT / BUILDING SERVICES ENGINEERS:</b>  19 DOMAIN ROAD, DOMANU SUVA, FIJI ISLANDS P.O. BOX 3872 SAMABULA, FIJI TELEPHONE: +679 330 2819 FACSIMILE: +679 330 2161 E-Mail: office@iap.com.fj	<b>ARCHITECT:</b>  <b>Architects + Master Planning</b> 88 MCGREGOR ROAD, SUVA, FIJI ISLANDS TEL: (679) 330 4043 FAX: (679) 330 4496 E-Mail: conway@carch.com.fj	<b>CLIENT:</b>  <b>LAND TRANSPORT AUTHORITY</b> LOT 1, DANIVA ROAD VALELEVU NASINU, FIJI ISLANDS P.O. BOX 8676, NASINU, FIJI TELEPHONE: +679 339 2166 FACSIMILE: +679 339 8922	<b>PROJECT:</b> <b>LTA KARAVI WEIGHBRIDGE STATION</b> KINGS ROAD, BA, FIJI ISLANDS	<b>SHEET TITLE:</b> <b>SCHEDULE OF DRAWINGS, LOCALITY PLAN, LEGENDS &amp; ABBREVIATIONS</b>	<b>DRAWING STATUS:</b> <b>FOR TENDER</b> <b>FOR PRICING</b> <b>FINAL DESIGN</b>	<b>DESIGNED:</b> RV <b>CHECKED:</b> RV / GY <b>START DATE:</b> 25 / 04 / 2018 <b>SCALE:</b> NTS	<b>DRAWN:</b> MM / ES <b>APPROVED:</b> GP / WY <b>ISSUE DATE:</b> 04 / 05 / 2019	<b>DISCIPLINE / SERVICES:</b> <b>FIRE PROTECTION</b> <b>JOB No:</b> 7835 <b>DWG No:</b> F01 <b>REVISION No:</b> -
--	---	--	---	--	--	--	--	--	---

**SPECIFICATION & SCOPE OF WORKS**

**A. GENERAL**

1. THESE DRAWINGS SHALL BE READ IN CONJUNCTION WITH ALL ARCHITECTURAL AND OTHER CONSULTANT'S DRAWINGS (INCLUDING THE CEILING CO-ORDINATED SERVICES DRAWINGS) AND SPECIFICATIONS AND WITH SUCH OTHER WRITTEN INSTRUCTIONS AS MAY BE ISSUED DURING THE COURSE OF THE CONTRACT.
2. ALL MATERIALS AND WORKMANSHIP SHALL BE IN ACCORDANCE WITH RELEVANT CODES AND AUTHORITIES HAVING JURISDICTION.
3. ALL DIMENSIONS SHOWN SHALL BE VERIFIED ON SITE. ENGINEER'S DRAWINGS SHALL NOT BE SCALED. ALL DIMENSIONS NOTED ARE IN MILLIMETERS UNLESS NOTED OTHERWISE.
4. SUPPLY, INSTALL, COMMISSION AND MAINTAIN FOR THE DEFECTS LIABILITY PERIOD ALL THE FIRE PROTECTION SERVICES AS SHOWN ON THE DRAWINGS. PROVIDE 'AS INSTALLED' DRAWINGS AND MAINTENANCE MANUALS AT PRACTICAL COMPLETION.
5. PROVIDE ALL NECESSARY PENETRATIONS THROUGH CONCRETE, BRICKWORK AND BUILDING FINISHES TO ACCOMMODATE PIPEWORK. PENETRATIONS SHALL BE SUBMITTED TO THE STRUCTURAL ENGINEER FOR APPROVAL PRIOR TO THEIR CONSTRUCTION. PENETRATIONS REQUIRED THROUGH CONSTRUCTED MATERIALS AND PRECAST SLABS SHALL BE CORE DRILLED. ALL PENETRATIONS ARE TO BE SEALED IN AN APPROVED MANNER.
6. TRENCH BACKFILLING UNDER PAVEMENTS AND BUILDING SLABS TO FORMATION LEVEL SHALL BE CLASS 3 FINE CRUSHED ROCK COMPACTED IN LAYERS OF 150MM MAXIMUM COMPACTED THICKNESS TO 95% STANDARD MAXIMUM DRY DENSITY.
7. APPLY TO THE LOCAL AUTHORITY FOR ALL NECESSARY PERMITS. PAY ALL FEES AND CHARGES.
8. CONSTRUCT ALL WORKS IN ACCORDANCE WITH THE NATIONAL BUILDING CODE.
9. THE FIRE PROTECTION SUB-CONTRACTOR SHALL CONFIRM THE FINAL POSITIONS OF EQUIPMENT ON SITE BEFORE CARRYING OUT INSTALLATION WORKS.
10. MAKE GOOD ALL DAMAGES TO EXISTING CONDITIONS.

**B. FIRE ALARM SYSTEM**

1. ALL INSTALLATION AND LOCATION OF EQUIPMENT SHALL BE IN ACCORDANCE WITH NZS4512.
2. ALL CABLING TO BE CONCEALED AND IN ACCORDANCE WITH NZS4512 AND AS/NZS3000.
3. SUPPLY AND INSTALL FIREPRO PIPE WRAPS B305 & B306 OR EQUAL APPROVED PENETRATION SEAL FOR ALL PENETRATIONS (INCLUDING SLEEVES AND FIREPROOF MASTIC SEALANT) THROUGH WALLS AND CEILING SLABS FOR ASSOCIATED CABLING.
4. ALL EXTRA LOW VOLTAGE SYSTEM CABLING TO BE A MINIMUM OF 300MM CLEARANCE FROM ELECTRICAL CABLES. WHEREVER THIS IS NOT ATTAINABLE, A METAL SEPARATION/BARRIER IS TO BE INSTALLED.
5. THE FIRE PROTECTION SUB-CONTRACTOR TO ALLOW FOR CATENARY WIRES AND SUITABLE SUPPORT SYSTEMS FOR THE CABLING. IN NO WAY ARE THE FIRE SERVICES TO INTERFERE WITH AND/OR USE SUPPORTS OF OTHER TRADES.

**C. FIRE HOSE REELS**

1. CONSTRUCT ALL WORKS IN ACCORDANCE WITH: THE NATIONAL BUILDING CODE, THE FIJI FIRE AUTHORITY AND THE FIJI PUBLIC WORKS DEPARTMENT.
2. ABOVE GROUND FIRE HOSE REEL PIPING SHALL BE GALVANIZED STEEL TO AS 1074. BELOW GROUND FIRE HOSE REEL PIPING SHALL BE COPPER TYPE B TO AS 1432 OR PE CLASS PN16 TO AS 4130 AND FIRE HYDRANTS TO BLUE BRUTE CLASS 16 TO AS 2977 WITH FITTINGS AND CONCRETE ANCHOR BLOCKS.
3. THE FIRE HOSE REELS AND FIRE HYDRANTS ARE TO BE SUPPLIED AND INSTALLED BY THE FIRE PROTECTION SUB-CONTRACTOR.


**D. SCOPE**

1. SUPPLY AND INSTALLATION OF THE COMPLETE AUTOMATIC CONVENTIONAL FIRE ALARM SYSTEM.
2. SUPPLY AND INSTALLATION OF THE FIRE INDICATING UNIT. (FIU)
3. SUPPLY AND INSTALLATION OF THE AUTOMATIC SMOKE AND HEAT DETECTORS.
4. SUPPLY AND INSTALLATION OF THE FIRE ALARM SOUNDERS. (INCLUDING IP65 RATED TYPES)
5. SUPPLY AND INSTALLATION OF THE VISUAL ALERT DEVICES(STROBE TYPE).
6. SUPPLY AND INSTALLATION OF THE MANUAL CALL POINTS.
7. SUPPLY AND INSTALLATION OF 36m STAINLESS STEEL FIRE HOSE REELS IN CABINET.
8. SUPPLY AND INSTALLATION OF FIRE SPEAKER CABLING.
9. SUPPLY AND INSTALLATION OF CONDUITS, CATENARY WIRE, FASTNERS AND ASSOCIATED ACCESSORIES.
10. SUPPLY AND INSTALLATION OF PORTABLE FIRE EXTINGUISHERS WITH THEIR ASSOCIATED ACCESSORIES. (HOOK AND BLAZON MOUNTED AT THE APPROPRIATE HEIGHT).
11. SUPPLY AND INSTALLATION OF THE FIRE ALARM SYSTEM CABLING.
12. OTHER TRADES INTERFACE CONNECTION OF FIRE ALARM SYSTEM.
13. SUPPLY & INSTALLATION OF ASSOCIATED ACCESSORIES.
14. TESTING & COMMISSIONING, INCLUDING INDEPENDENT INSPECTION.
15. 12 MONTHS MONTHLY MAINTENANCE.
16. SUPPLY OF SPARES.
17. AS INSTALLED DRAWINGS & MAINTENANCE MANUALS.

<p>© COPYRIGHT OF THIS DRAWING SHALL REMAIN THE PROPERTY OF IRWIN ALSOP PACIFIC PTE LTD. PRECEDENCE SHALL BE GIVEN TO THE LARGEST SCALE DRAWING. THE CONTRACTOR SHALL VERIFY ALL DIMENSIONS ON SITE PRIOR TO PREPARATION OF SHOP DRAWINGS OR COMMENCEMENT OF ANY WORK. THE ENGINEER SHALL BE NOTIFIED IMMEDIATELY OF ANY DISCREPANCIES.</p>	<p>LEAD CONSULTANT / BUILDING SERVICES ENGINEERS:</p>  <p>19 DOMAN ROAD, DOMAN SUVA, FIJI ISLANDS P.O. BOX 3872 SAMABULA, FIJI TELEPHONE: +679 330 2819 FACSIMILE: +679 330 2161 E-Mail: office@iap.com.fj</p>	<p>ARCHITECT:</p>  <p>88 MCGREGOR ROAD, SUVA, FIJI ISLANDS TEL: (679) 330 4043 FAX: (679) 330 4496 E-Mail: conway@carc.com.fj</p>	<p>CLIENT:</p>  <p>LAND TRANSPORT AUTHORITY LOT 1, DANIVA ROAD VALELEVU NASINU, FIJI ISLANDS P.O. BOX 8676, NASINU, FIJI TELEPHONE: +679 339 2166 FACSIMILE: +679 339 8923</p>	<p>PROJECT:</p> <p>LTA KARAVI WEIGHBRIDGE STATION KINGS ROAD, BA, FIJI ISLANDS</p>	<p>SHEET TITLE:</p> <p>SPECIFICATION &amp; SCOPE OF WORKS</p>	<p>DRAWING STATUS:</p> <p><b>FOR TENDER</b></p> <p>ACTION:</p> <p><b>FOR PRICING</b></p> <p>WORK STAGE:</p> <p><b>FINAL DESIGN</b></p>	<p>DESIGNED: RV</p>	<p>DRAWN: MM / ES</p>	<p>DISCIPLINE / SERVICES:</p> <p><b>FIRE PROTECTION</b></p>
							<p>CHECKED: RV / GY</p>	<p>APPROVED: GP / WY</p>	
							<p>START DATE: 25 / 04 / 2018</p>	<p>ISSUE DATE: 04 / 05 / 2019</p>	
							<p>SCALE: NTS</p>	<p>JOB No: 7835</p> <p>DWG No: F02</p> <p>REVISION No: -</p>	

NOTES:

- A** PREFERRED LOCATION OF 36m FIRE HOSE REEL.
- B** LOCATION FOR THE FIRE INDICATING UNIT.

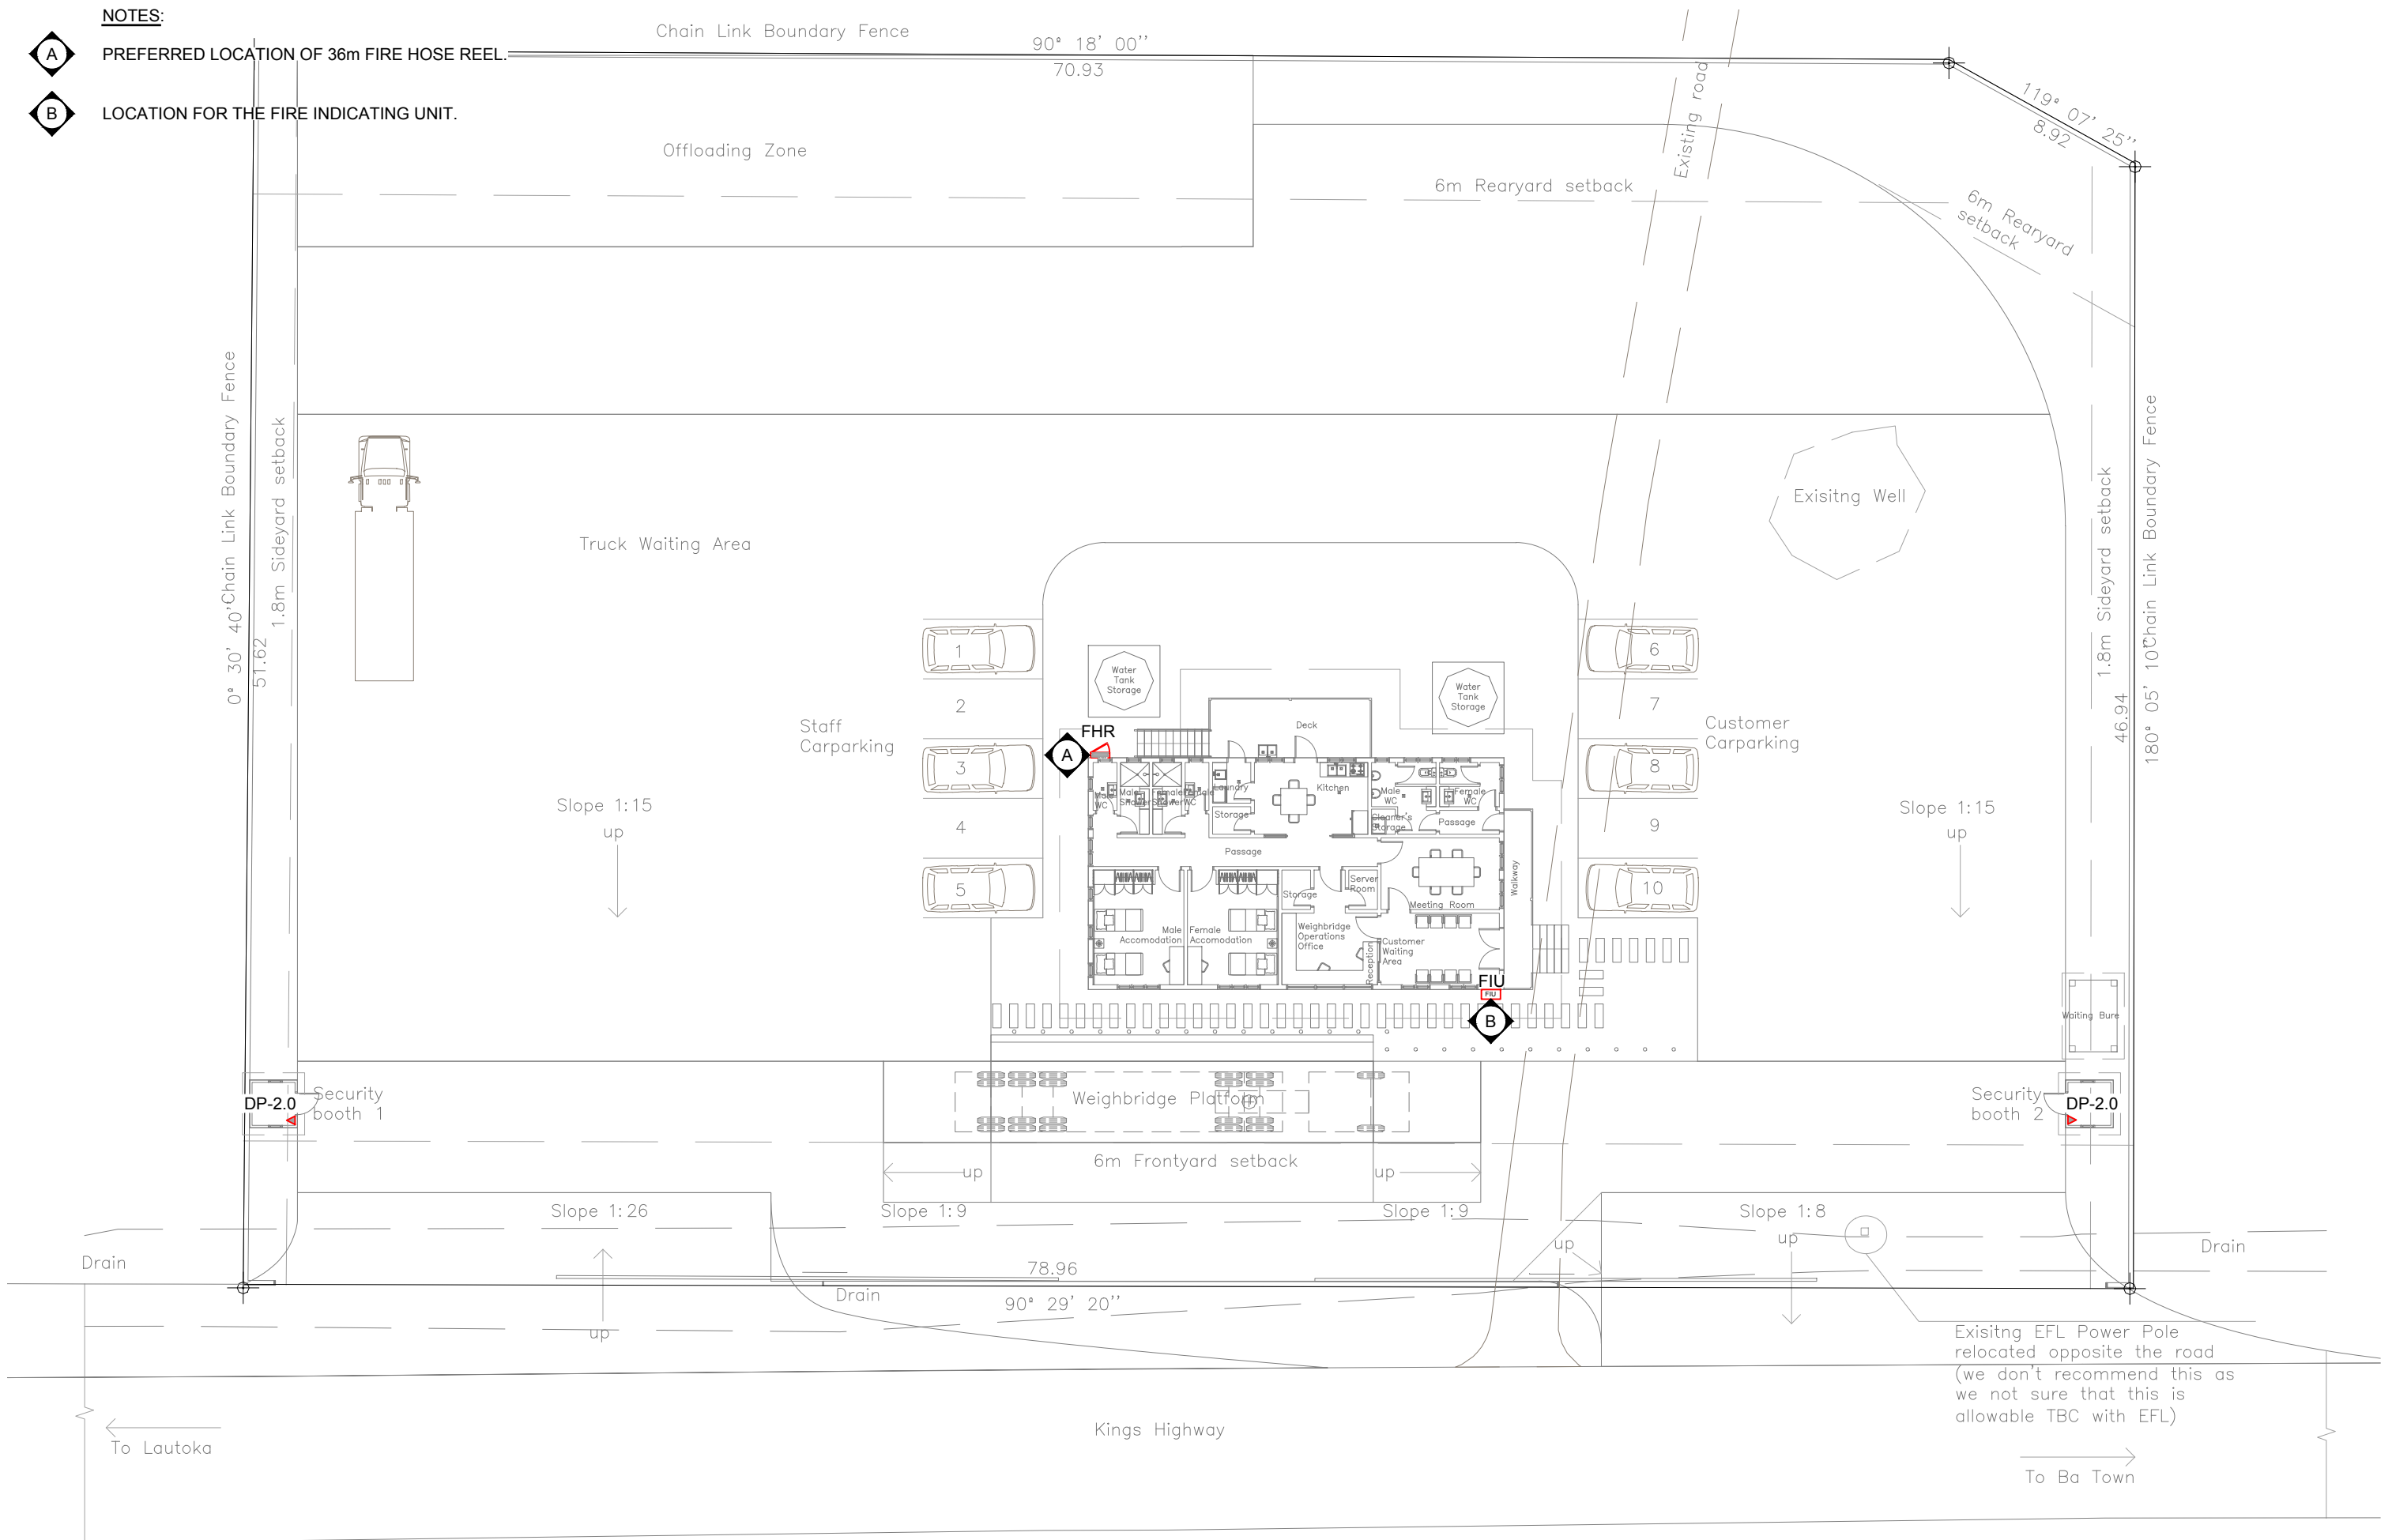


<p>© COPYRIGHT OF THIS DRAWING SHALL REMAIN THE PROPERTY OF IRWIN ALSOP PACIFIC PTE LTD. PRECEDENCE SHALL BE GIVEN TO THE LARGEST SCALE DRAWING. THE CONTRACTOR SHALL VERIFY ALL DIMENSIONS ON SITE PRIOR TO PREPARATION OF SHOP DRAWINGS OR COMMENCEMENT OF ANY WORK. THE ENGINEER SHALL BE NOTIFIED IMMEDIATELY OF ANY DISCREPANCIES.</p>	<p>LEAD CONSULTANT / BUILDING SERVICES ENGINEERS:</p> <p><b>IAP</b> Irwin Alsop Pacific</p> <p>19 DOMAIN ROAD, DOMANU SUVA, FIJI ISLANDS P.O. BOX 3872 SAMABULA, SUVA TELEPHONE: +679 330 2819 FACSIMILE: +679 330 2161 E-Mail: office@iap.com.fj</p>	<p>ARCHITECT:</p> <p><b>conway architects</b> Architects + Master Planning</p> <p>88 MCGREGOR ROAD, SUVA, FIJI ISLANDS TEL: (679) 330 4043 FAX: (679) 330 4496 E-Mail: conway@carc.com.fj</p>	<p>CLIENT:</p> <p><b>LTA</b> LAND TRANSPORT AUTHORITY</p> <p>LOT 1, DANIVA ROAD VALELEVU NASINU, FIJI ISLANDS P.O. BOX 8676, NASINU, FIJI TELEPHONE: +679 339 2166 FACSIMILE: +679 339 8923</p>	<p>PROJECT:</p> <p><b>LTA KARAVI WEIGHBRIDGE STATION</b> KINGS ROAD, BA, FIJI ISLANDS</p>	<p>SHEET TITLE:</p> <p><b>PROPOSED SITE PLAN FIRE PROTECTION LAYOUTS</b></p>	<p>DRAWING STATUS:</p> <p><b>FOR TENDER</b></p> <p>ACTION:</p> <p><b>FOR PRICING</b></p> <p>WORK STAGE:</p> <p><b>FINAL DESIGN</b></p>	<table border="1" style="width: 100%; border-collapse: collapse;"> <tr> <td>DESIGNED: RV</td> <td>DRAWN: MM / ES</td> </tr> <tr> <td>CHECKED: RV / GY</td> <td>APPROVED: GP / WY</td> </tr> <tr> <td>START DATE: 25 / 04 / 2018</td> <td>ISSUE DATE: 04 / 05 / 2019</td> </tr> <tr> <td colspan="2">SCALE: 1 : 250 @ A3</td> </tr> </table>	DESIGNED: RV	DRAWN: MM / ES	CHECKED: RV / GY	APPROVED: GP / WY	START DATE: 25 / 04 / 2018	ISSUE DATE: 04 / 05 / 2019	SCALE: 1 : 250 @ A3		<p>DISCIPLINE / SERVICES:</p> <p><b>FIRE PROTECTION</b></p> <table border="1" style="width: 100%; border-collapse: collapse;"> <tr> <td>JOB No:</td> <td>DWG No:</td> <td>REVISION No:</td> </tr> <tr> <td>7835</td> <td>F03</td> <td>-</td> </tr> </table>	JOB No:	DWG No:	REVISION No:	7835	F03	-
DESIGNED: RV	DRAWN: MM / ES																					
CHECKED: RV / GY	APPROVED: GP / WY																					
START DATE: 25 / 04 / 2018	ISSUE DATE: 04 / 05 / 2019																					
SCALE: 1 : 250 @ A3																						
JOB No:	DWG No:	REVISION No:																				
7835	F03	-																				


NOTES:

**A** PREFERRED LOCATION OF 36m FIRE HOSE REEL.


**B** LOCATION FOR THE RECESSED FIRE INDICATING UNIT.

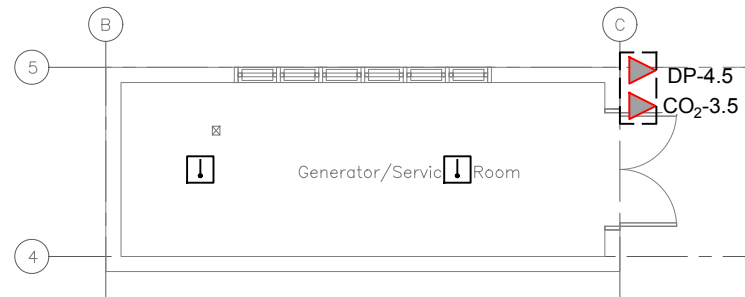

**2** GENERATOR ROOM FLOOR PLAN  
F04 1 : 100 @ A3

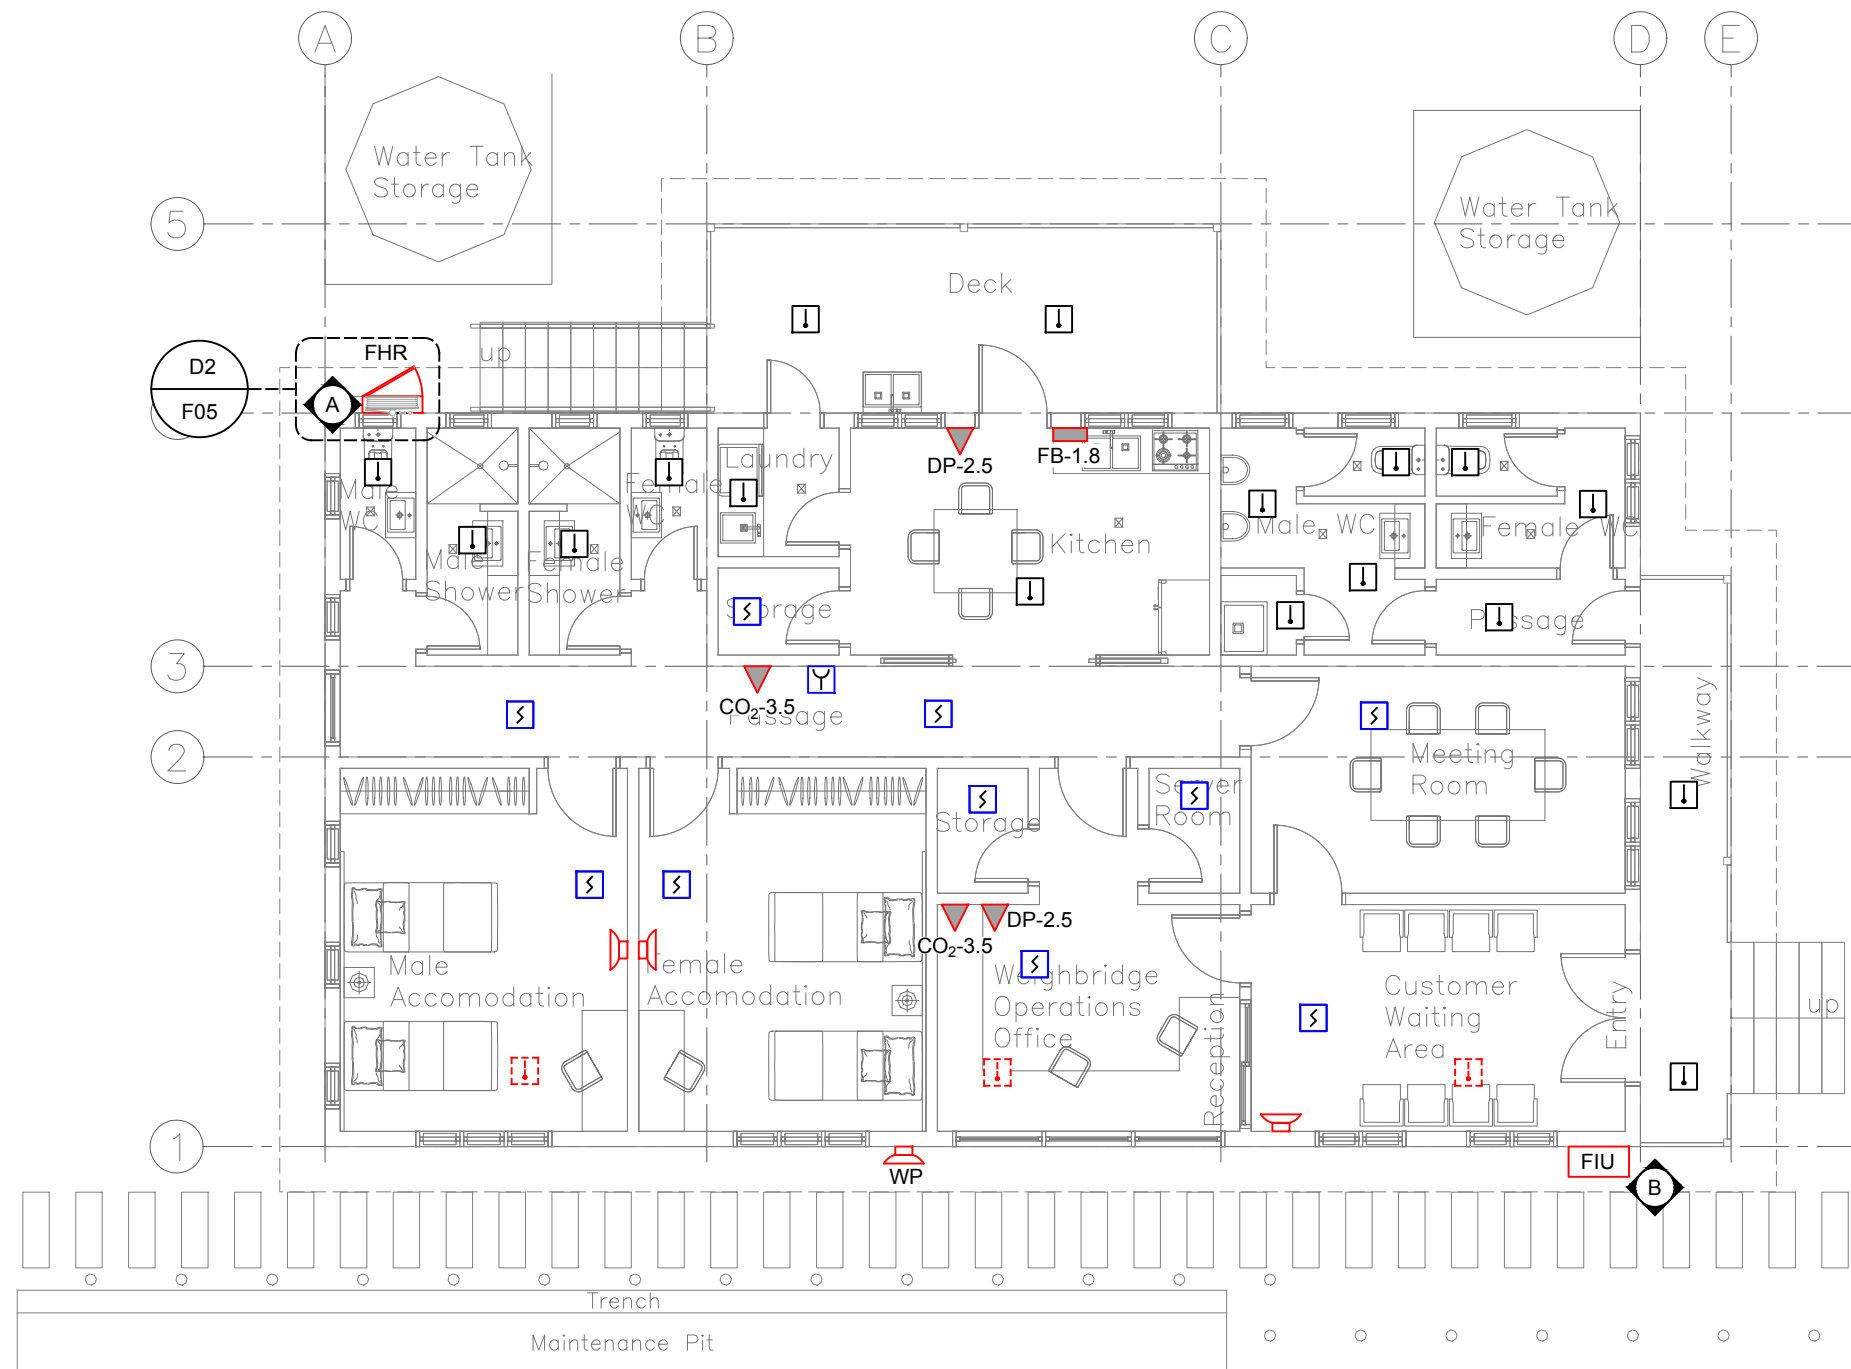


**1** OFFICE FLOOR PLAN  
F04 1 : 100 @ A3

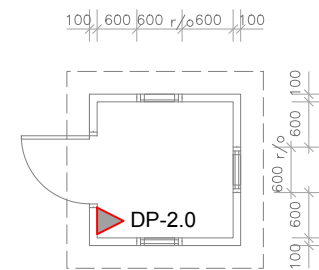

**3** TYPICAL SECURITY BOOTH FLOOR PLAN  
F04 1 : 100 @ A3

<p>© COPYRIGHT OF THIS DRAWING SHALL REMAIN THE PROPERTY OF IRWIN ALSOP PACIFIC PTE LTD. PRECEDENCE SHALL BE GIVEN TO THE LARGEST SCALE DRAWING. THE CONTRACTOR SHALL VERIFY ALL DIMENSIONS ON SITE PRIOR TO PREPARATION OF SHOP DRAWINGS OR COMMENCEMENT OF ANY WORK. THE ENGINEER SHALL BE NOTIFIED IMMEDIATELY OF ANY DISCREPANCIES.</p>	<p>LEAD CONSULTANT / BUILDING SERVICES ENGINEERS:</p> <p><b>IAP</b> Irwin Alsop Pacific 19 DOMAIN ROAD, DOMANU SUVA, FIJI ISLANDS P.O. BOX 3872 SAMABUSA, FIJI TELEPHONE: +679 330 2819 FACSIMILE: +679 330 2167 E-Mail: office@iap.com.fj</p>	<p>ARCHITECT:</p> <p><b>conway architects</b> Architects + Master Planning 88 MCGREGOR ROAD, SUVA, FIJI ISLANDS TEL: (679) 330 4043 FAX: (679) 330 4496 E-Mail: conway@carch.com.fj</p>	<p>CLIENT:</p> <p><b>LTA</b> LAND TRANSPORT AUTHORITY LOT 1, DANIVA ROAD VALELEVU NASINU, FIJI ISLANDS P.O. BOX 8676, NASINU, FIJI TELEPHONE: +679 339 2166 FACSIMILE: +679 339 8923</p>	<p>PROJECT:</p> <p><b>LTA KARAVI WEIGHBRIDGE STATION</b> KINGS ROAD, BA, FIJI ISLANDS</p>	<p>SHEET TITLE:</p> <p><b>PROPOSED FLOOR PLANS FIRE PROTECTION LAYOUTS</b></p>	<p>DRAWING STATUS:</p> <p><b>FOR TENDER</b> <b>FOR PRICING</b> <b>FINAL DESIGN</b></p>	<p>DESIGNED: RV CHECKED: RV / GY START DATE: 25 / 04 / 2018 SCALE: 1 : 100 @ A3</p>	<p>DRAWN: MM / ES APPROVED: GP / WY ISSUE DATE: 04 / 05 / 2019</p>	<p>DISCIPLINE / SERVICES:</p> <p><b>FIRE PROTECTION</b></p>	<p>JOB No: 7835 DWG No: F04 REVISION No: -</p>	
	<p>1 24 / 05 / 2019 FOR TENDER IAP</p>	<p>BY:</p>	<p>DATE DESCRIPTION</p>	<p>1 24 / 05 / 2019 FOR TENDER IAP</p>	<p>DATE DESCRIPTION</p>	<p>DATE DESCRIPTION</p>	<p>DATE DESCRIPTION</p>	<p>DATE DESCRIPTION</p>	<p>DATE DESCRIPTION</p>	<p>DATE DESCRIPTION</p>	<p>DATE DESCRIPTION</p>
	<p>No: DATE DESCRIPTION</p>	<p>BY:</p>	<p>DATE DESCRIPTION</p>	<p>No: DATE DESCRIPTION</p>	<p>BY:</p>	<p>DATE DESCRIPTION</p>	<p>No: DATE DESCRIPTION</p>	<p>BY:</p>	<p>No: DATE DESCRIPTION</p>	<p>BY:</p>	<p>No: DATE DESCRIPTION</p>
	<p>No: DATE DESCRIPTION</p>	<p>BY:</p>	<p>DATE DESCRIPTION</p>	<p>No: DATE DESCRIPTION</p>	<p>BY:</p>	<p>DATE DESCRIPTION</p>	<p>No: DATE DESCRIPTION</p>	<p>BY:</p>	<p>No: DATE DESCRIPTION</p>	<p>BY:</p>	<p>No: DATE DESCRIPTION</p>

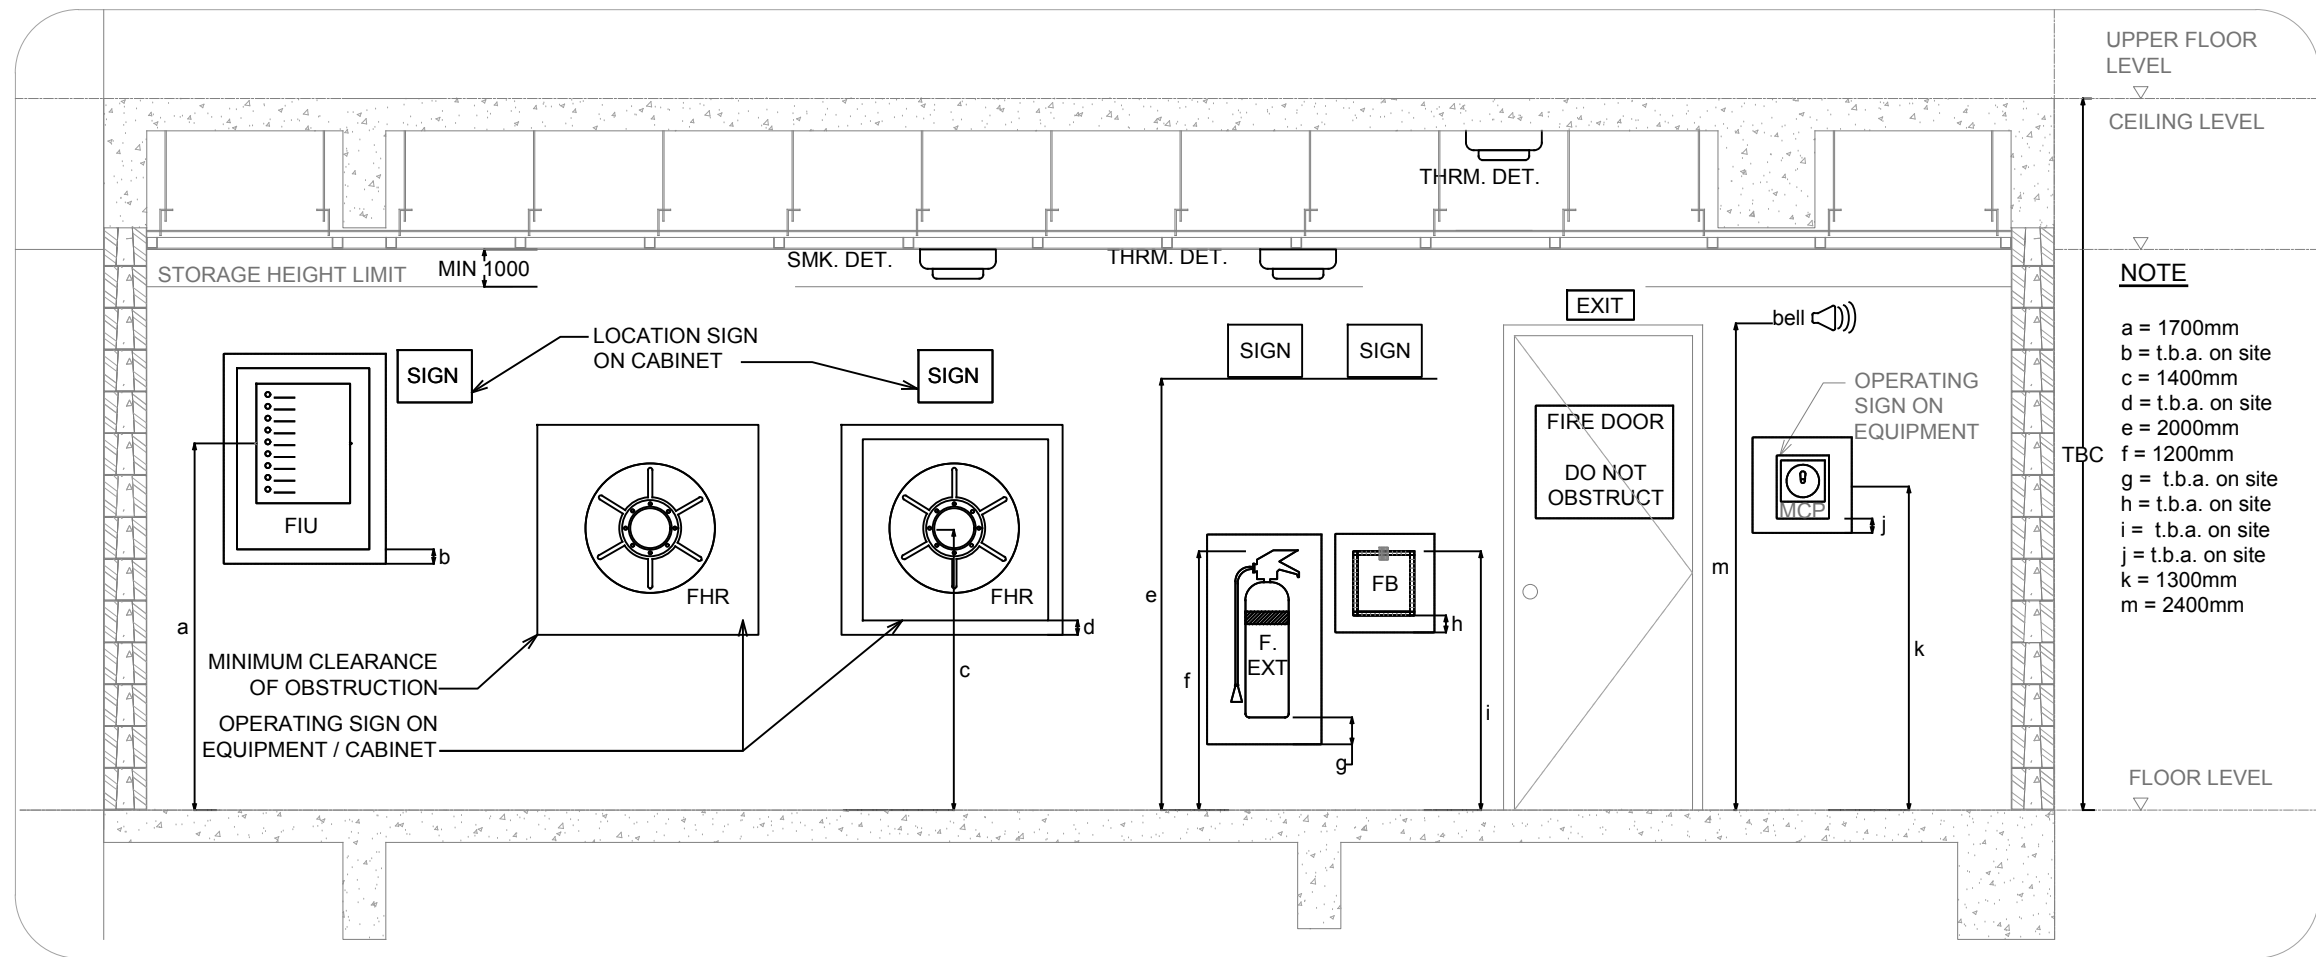


**NOTE**

a = 1700mm  
 b = t.b.a. on site  
 c = 1400mm  
 d = t.b.a. on site  
 e = 2000mm  
 f = 1200mm  
 g = t.b.a. on site  
 h = t.b.a. on site  
 i = t.b.a. on site  
 j = t.b.a. on site  
 k = 1300mm  
 m = 2400mm

D1 FIRE PROTECTION DETAILS, HEIGHT RESTRICTIONS OF FIRE PROTECTION EQUIPMENT  
 F05 SCALE: NTS

**NOTE:**  
 COMPLETE FIRE HOSE REEL WITH SURFACE MOUNTED STAINLESS STEEL CABINET AND ASSOCIATED ACCESSORIES SUPPLIED AND INSTALLED BY FIRE PROTECTION SUB-CONTRACTOR.

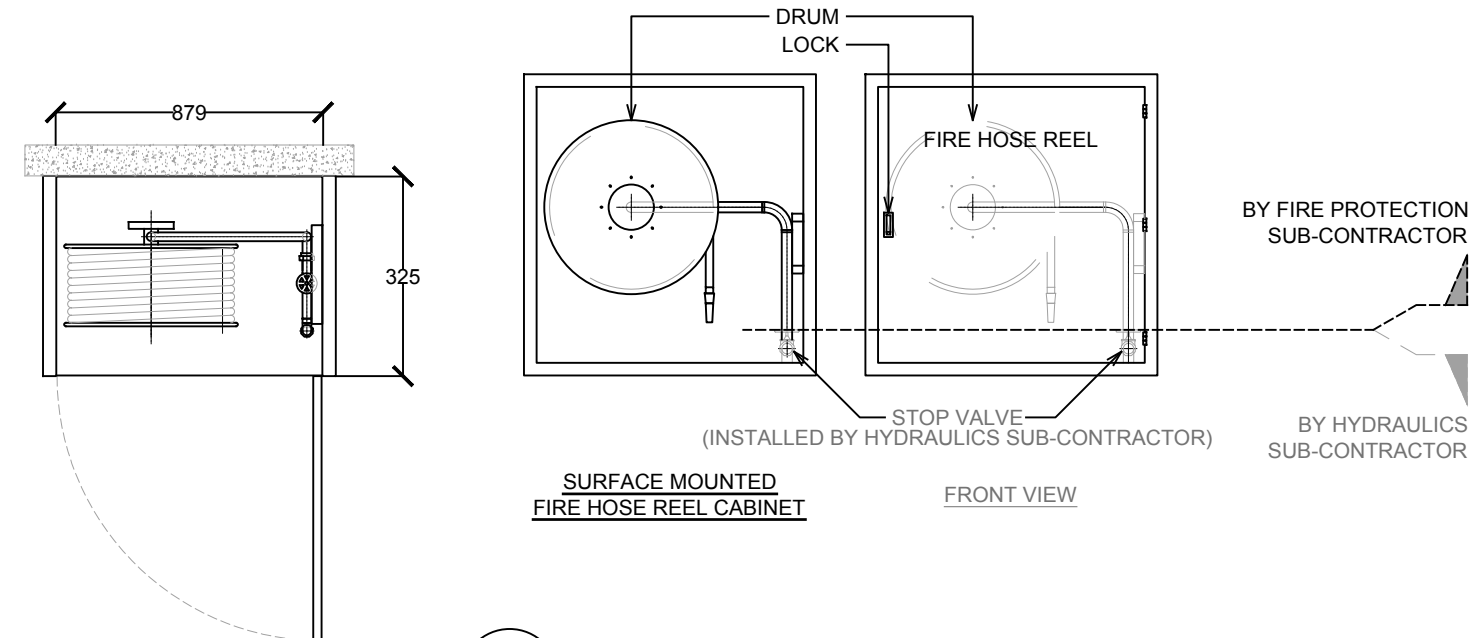

D2 TYPICAL FIRE HOSE REEL DETAIL  
 F05 SCALE: NTS

© COPYRIGHT OF THIS DRAWING SHALL REMAIN THE PROPERTY OF IRWIN ALSOP PACIFIC PTE LTD. PRECEDENCE SHALL BE GIVEN TO THE LARGEST SCALE DRAWING. THE CONTRACTOR SHALL VERIFY ALL DIMENSIONS ON SITE PRIOR TO PREPARATION OF SHOP DRAWINGS OR COMMENCEMENT OF ANY WORK. THE ENGINEER SHALL BE NOTIFIED IMMEDIATELY OF ANY DISCREPANCIES.	<b>LEAD CONSULTANT / BUILDING SERVICES ENGINEERS:</b> 19 DOMAIN ROAD, DOMANI SUVA, FIJI ISLANDS P.O. BOX 3872 SAMABULA, FIJI TELEPHONE: +679 330 2819 FACSIMILE: +679 330 2161 E-Mail: office@iap.com.fj		<b>ARCHITECT:</b> <b>conway architects</b> Architects + Master Planning 88 MCGREGOR ROAD, SUVA, FIJI ISLANDS TEL: (679) 330 4043 FAX: (679) 330 4496 E-Mail: conway@carch.com.fj		<b>CLIENT:</b> <b>LAND TRANSPORT AUTHORITY</b> LOT 1, DANIVA ROAD VALELEVU NASINU, FIJI ISLANDS P.O. BOX 8676, NASINU, FIJI TELEPHONE: +679 339 2166 FACSIMILE: +679 339 8922		<b>PROJECT:</b> <b>LTA KARAVI WEIGHBRIDGE STATION</b> KINGS ROAD, BA, FIJI ISLANDS		<b>SHEET TITLE:</b> <b>PROPOSED FIRE PROTECTION DETAILS</b>		<b>DRAWING STATUS:</b> <b>FOR TENDER</b> <b>FOR PRICING</b> <b>FINAL DESIGN</b>		<b>DESIGNED:</b> RV <b>CHECKED:</b> RV / GY <b>START DATE:</b> 25 / 04 / 2018 <b>SCALE:</b> NTS		<b>DRAWN:</b> MM / ES <b>APPROVED:</b> GP / WY <b>ISSUE DATE:</b> 04 / 05 / 2019		<b>DISCIPLINE / SERVICES:</b> <b>FIRE PROTECTION</b>		
	No: 1 DATE: 24 / 05 / 2019 DESCRIPTION: FOR TENDER		IAP		LTA		LTA KARAVI WEIGHBRIDGE STATION		PROPOSED FIRE PROTECTION DETAILS		FOR TENDER		RV		MM / ES		FIRE PROTECTION		
	No: 1 DATE: 24 / 05 / 2019 DESCRIPTION: FOR TENDER		IAP		LTA		LTA KARAVI WEIGHBRIDGE STATION		PROPOSED FIRE PROTECTION DETAILS		FOR TENDER		RV		MM / ES		FIRE PROTECTION		
	No: 1 DATE: 24 / 05 / 2019 DESCRIPTION: FOR TENDER		IAP		LTA		LTA KARAVI WEIGHBRIDGE STATION		PROPOSED FIRE PROTECTION DETAILS		FOR TENDER		RV		MM / ES		FIRE PROTECTION		
No: 1 DATE: 24 / 05 / 2019 DESCRIPTION: FOR TENDER		IAP		LTA		LTA KARAVI WEIGHBRIDGE STATION		PROPOSED FIRE PROTECTION DETAILS		FOR TENDER		RV		MM / ES		FIRE PROTECTION			